

FOR CONTINUATION SEE MKS-MET-ZZ-ZZ-DR-E-6001B

This drawing is the copyright of METEC Consulting Engineers and may not be reproduced in whole or in part without their expressed written permission. All figured dimensions are to be verified on site and any discrepancy is to be reported to the Engineer immediately.




LEGEND OF SYMBOLS

1	TYPE 1 - KREOS SR/150 PERFORMANCE LIGHTING
2	TYPE 2 - DUO LUNA (MOD/M) PERFORMANCE LIGHTING
3	TYPE 3 - HEDO+FT SR/075 PERFORMANCE LIGHTING
4	TYPE 4 - KREOS SR/100 PERFORMANCE LIGHTING
5	TYPE 5 - IWAY SUPER-COMFORT GUZZINI
6	TYPE 6 - WALKY SQUARE GUZZINI
7	TYPE 7 - HEDO+FT PERFORMANCE LIGHTING
8	TYPE 8 - PALCO IN/OUT GUZZINI
9	TYPE 9 - LIGHT UP EARTH GUZZINI
10	TYPE 10 - IWAY SUPER-COMFORT GUZZINI
11	TYPE 11 - ATON P88 ALDABRA

1 LUX LIGHTING ISOLINES - INDICATES BOUNDARY LUX LEVELS



TYPE 1 KREOS SR/150 (PERFORMANCE LIGHTING) MOUNTED ON TIMBERLAB PILA POLE
 TYPE 2 DUO LUNA (L MOD/M) (KKDC)
 TYPE 3 HEDO+FT SR/075 (PERFORMANCE LIGHTING) MOUNTED ON TIMBERLAB PILA POLE
 TYPE 4 KREOS SR/100 (PERFORMANCE LIGHTING) MOUNTED ON TIMBERLAB PILA POLE

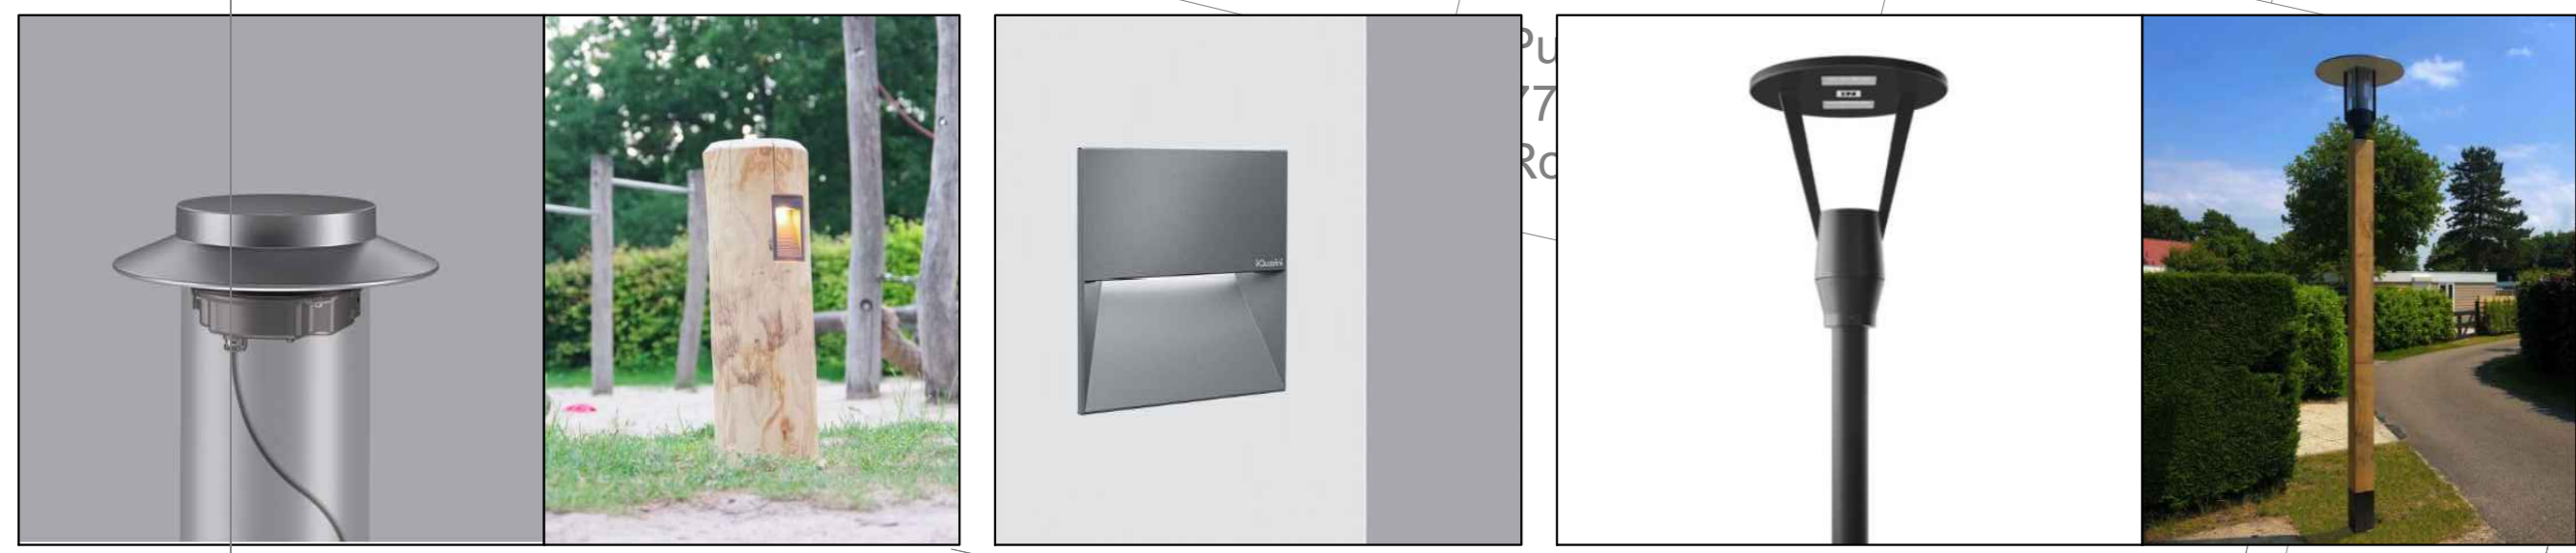

TYPE 5 IWAY SUPER-COMFORT (GUZZINI) INTEGRATED INTO TIMBERLAB PIATTO
 TYPE 6 WALKY SQUARE (GUZZINI)
 TYPE 7 HEDO+FT (PERFORMANCE LIGHTING) MOUNTED ON TIMBERLAB PILA POLE



PO4	JUN '23	FURTHER INFORMATION ISSUE
PO3	MAY '23	PLANNING ISSUE
PO2	MAR '23	PLANNING ISSUE
PO1	NOV '22	PLANNING ISSUE
REV	DATE	DESCRIPTION

metec
 CONSULTING ENGINEERS
 mechanical • electrical • energy

project: DALGUISE MONKSTOWN
 client:
 drawing title: SITE LIGHTING LAYOUT SHEET 1 OF 2
 drawing no: 21044
 drawing title: MKS-MET-ZZ-ZZ-DR-E-6001A
 drawn by: JM
 checked by: EP
 approved by: MR
 date: APR '22
 scale: 1:200 @A0
 sheet no: P04

FOR CONTINUATION SEE MKS-MET-ZZ-ZZ-DR-E-6001B