


LEGEND OF SYMBOLS

- 1 TYPE 1 - KREIG SR/50 PERFORMANCE LIGHTING
- 2 TYPE 2 - DUO LUNA (1W/2/4/8/16) PERFORMANCE LIGHTING
- 3 TYPE 3 - HED+FT SR/075 PERFORMANCE LIGHTING
- 4 TYPE 4 - KREIG SR/100 PERFORMANCE LIGHTING
- 5 TYPE 5 - IMAX SUPER-COMFORT QUZZINI
- 6 TYPE 6 - WALKY SQUARE QUZZINI
- 7 TYPE 7 - HED+FT PERFORMANCE LIGHTING
- 8 TYPE 8 - PALDO IN/OUT QUZZINI
- 9 TYPE 9 - LIGHT UP EARTH QUZZINI
- 10 TYPE 10 - IMAX SUPER-COMFORT QUZZINI
- 11 TYPE 11 - ATON P88 ALDARA

1 LUX LIGHTING ISOINES - INDICATES BOUNDARY LUX LEVELS

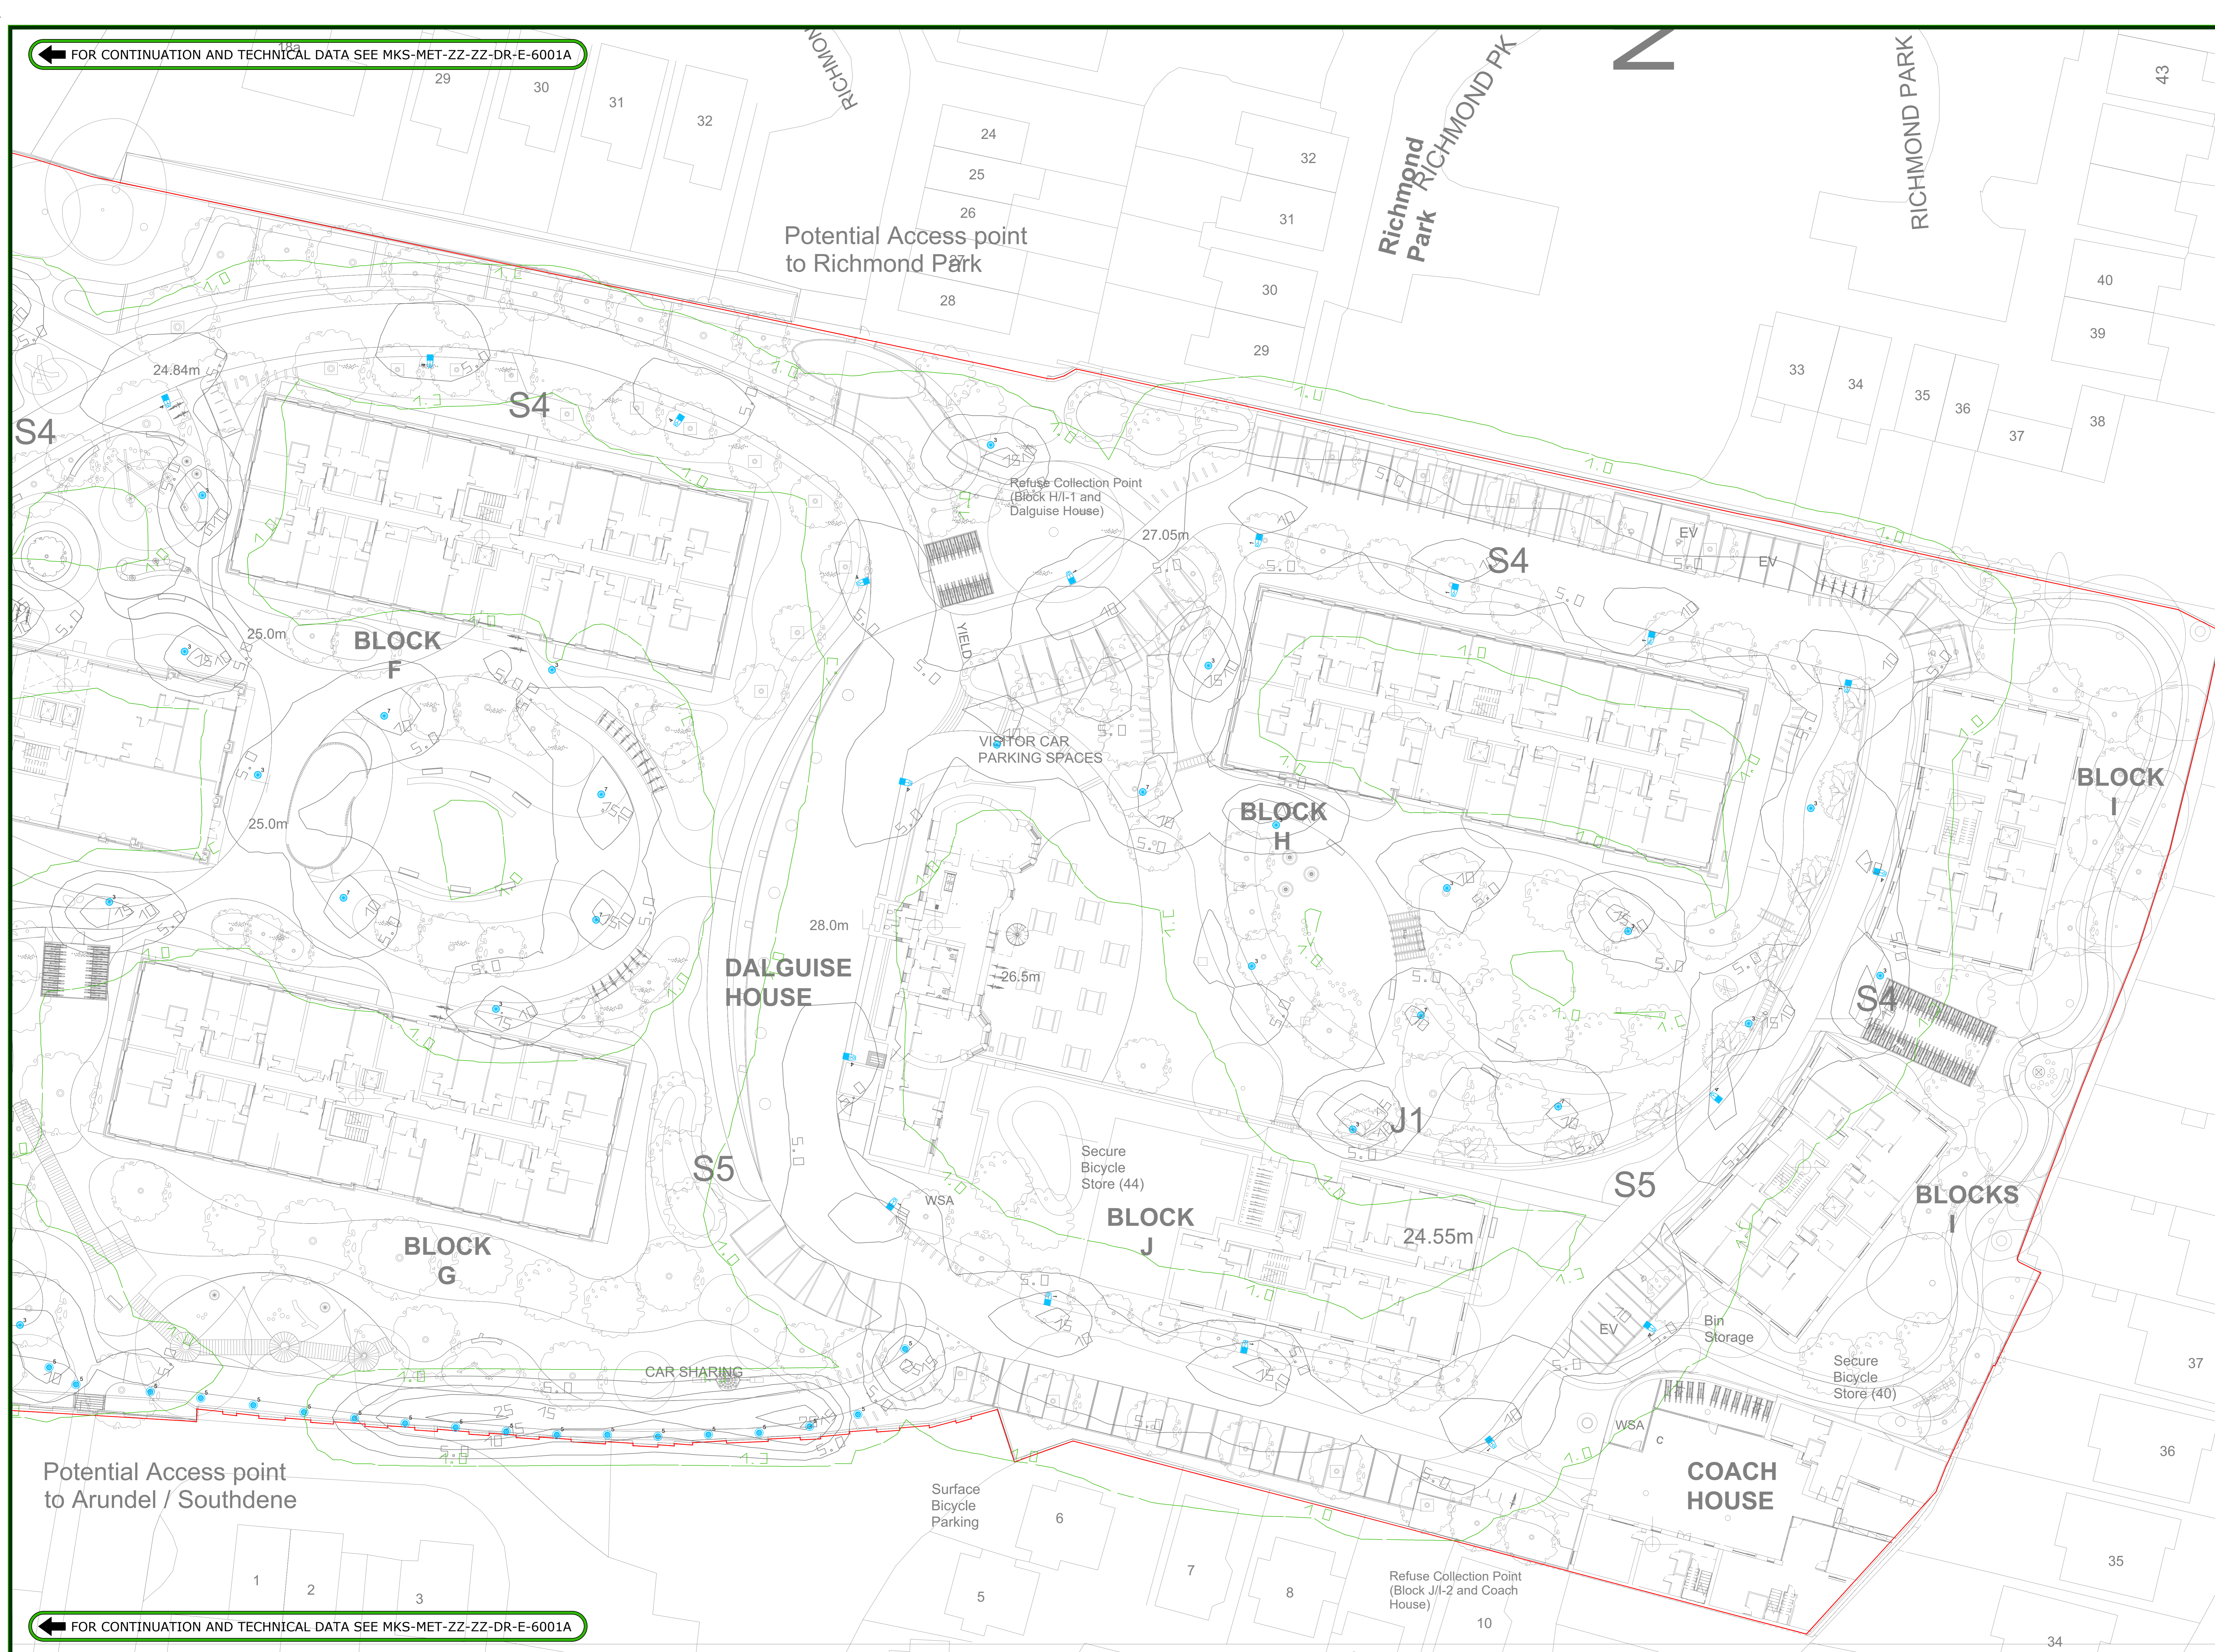

Potential Access point to Arundel / Southdene

Potential Access point to Richmond Park

rev	date	description
P04	JUN '23	FORNISH INFORMATION ISSUE
P03	MAY '23	PLANNING ISSUE
P02	MAR '23	PLANNING ISSUE
P01	OCT '22	PLANNING ISSUE



DALGUISE MONKSTOWN



SITE LIGHTING LAYOUT SHEET 2 OF 2

proj no:	21044	drawing no:	MKS-MET-ZZ-ZZ-DR-E-6001B
client:	JM	checked by:	MR
date:	APR '22	scale:	1:200 @A0
		rev no:	P04